
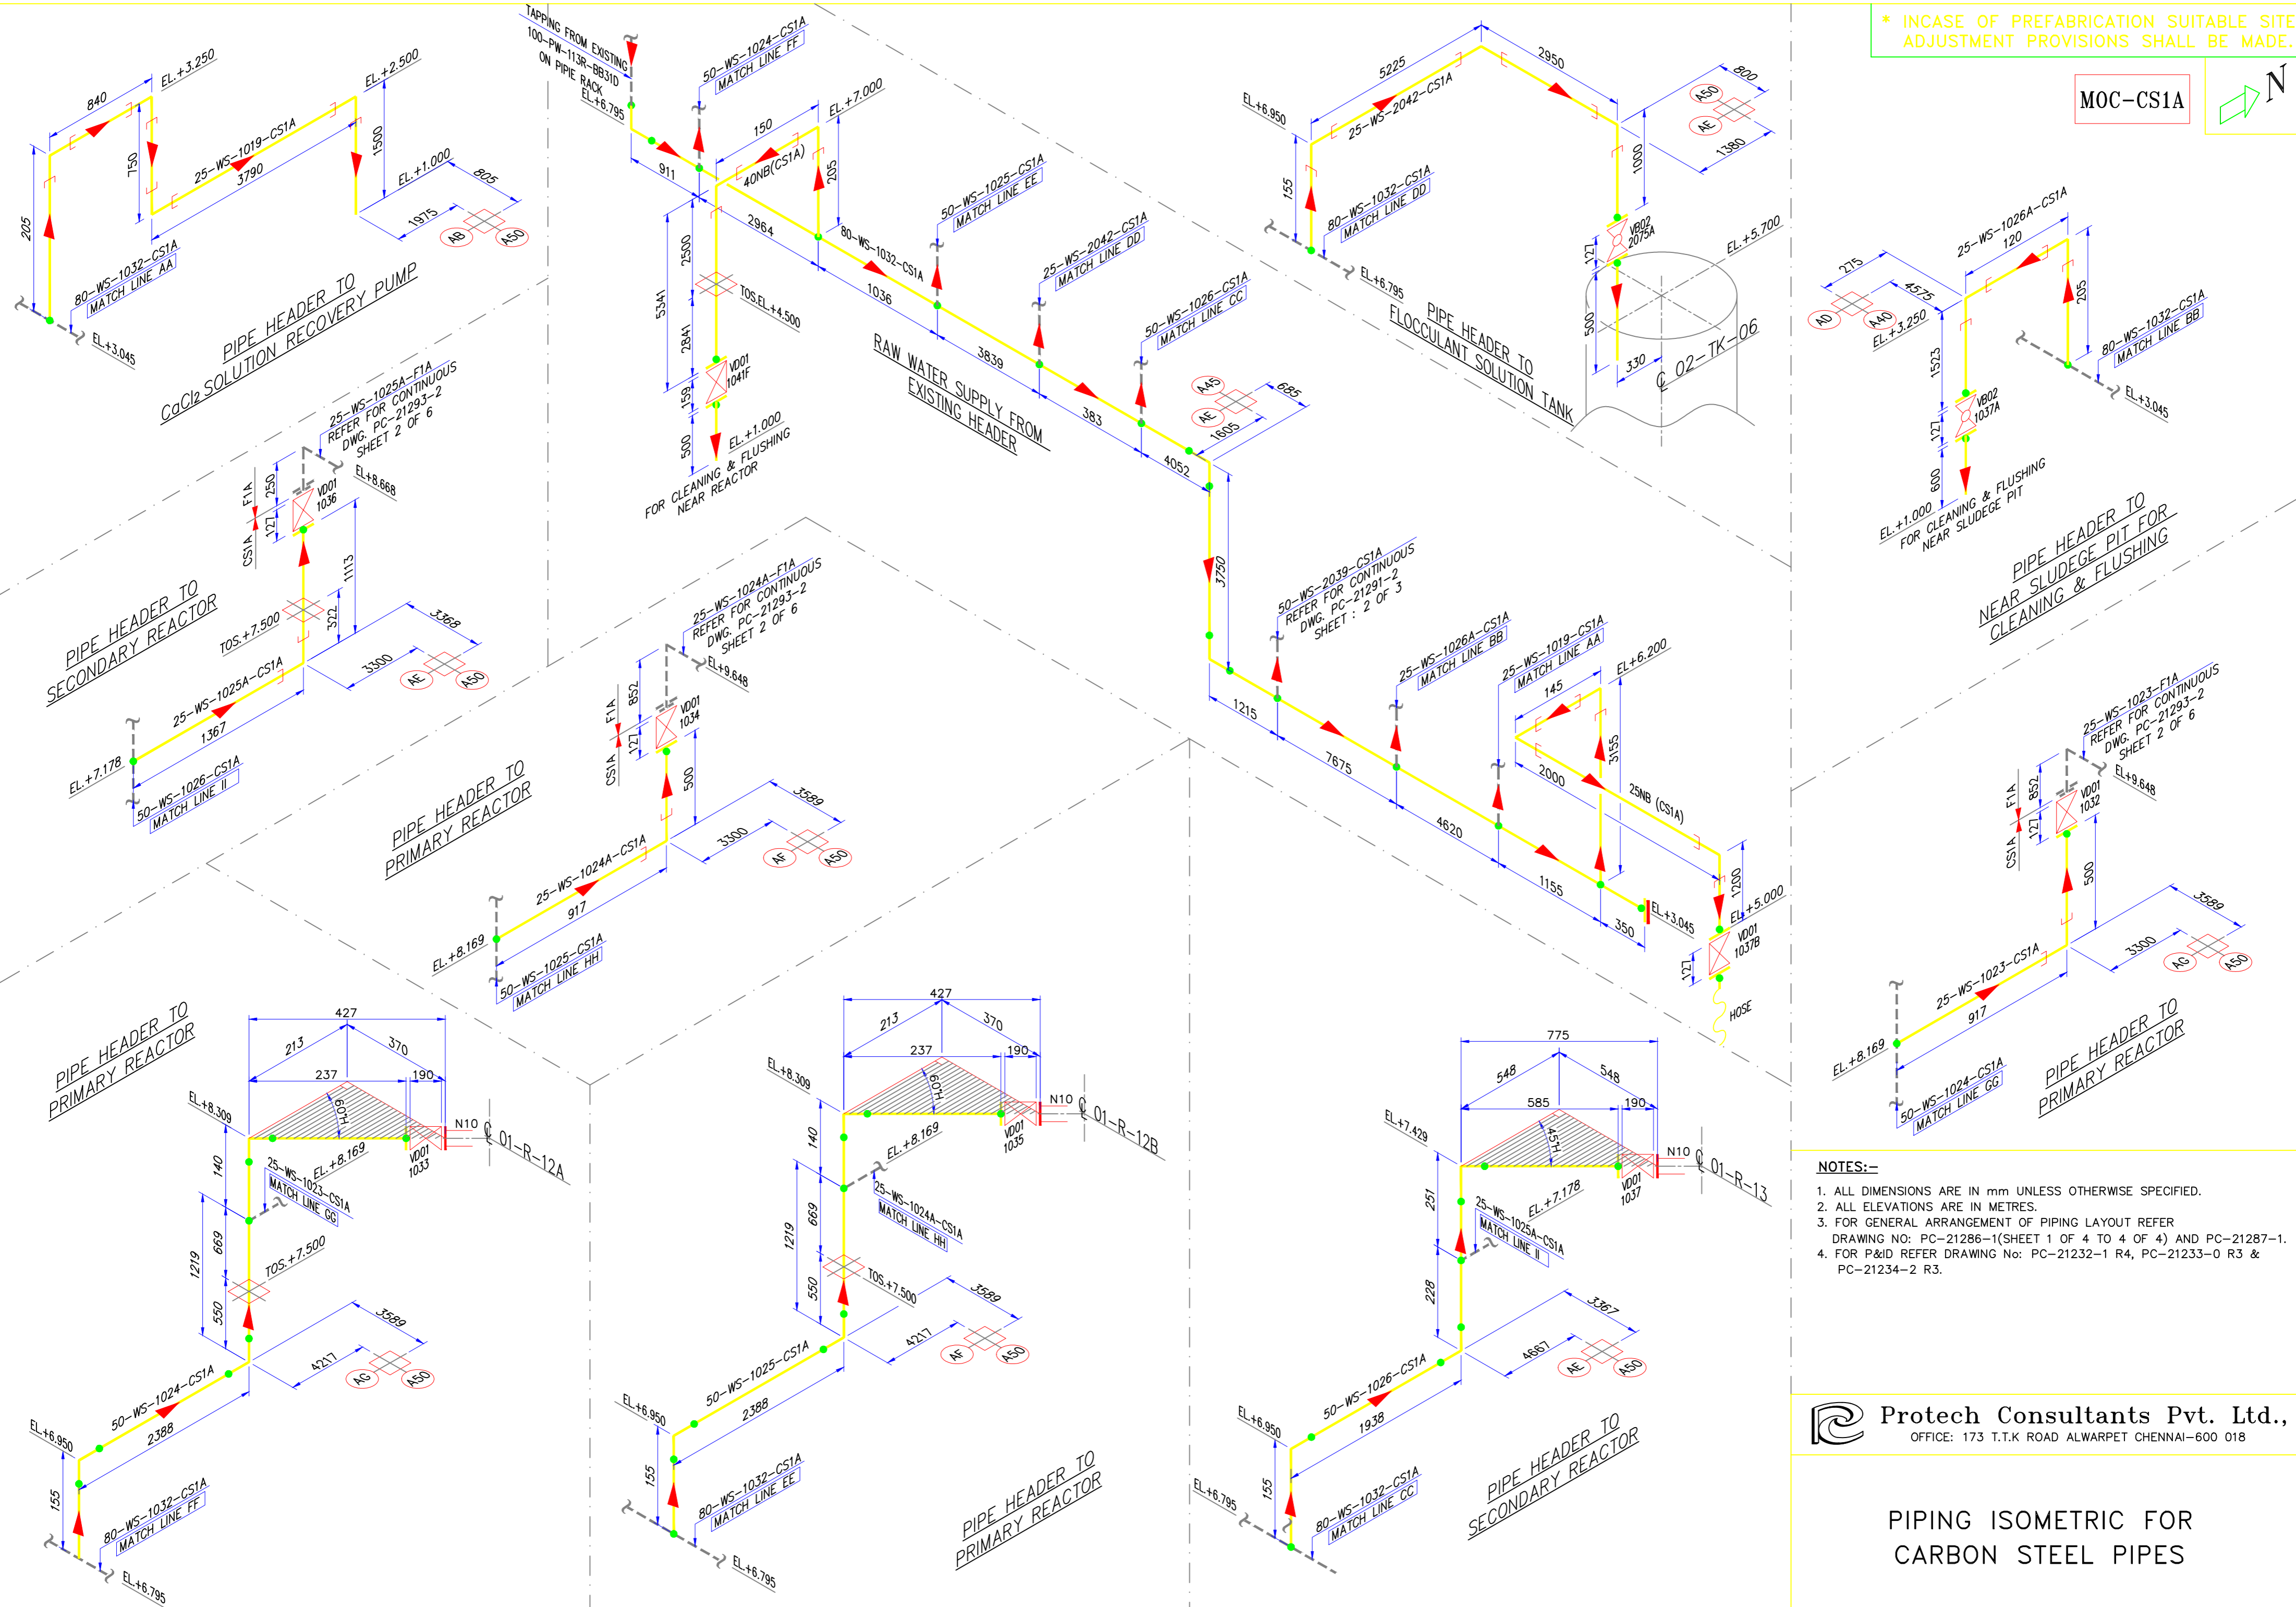


*INCAUSE OF PREFABRICATION SUITABLE SITE ADJUSTMENT PROVISIONS SHALL BE MADE.

MOC-CS1A

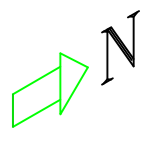

- NOTES:-**
1. ALL DIMENSIONS ARE IN mm UNLESS OTHERWISE SPECIFIED.
 2. ALL ELEVATIONS ARE IN METRES.
 3. FOR GENERAL ARRANGEMENT OF PIPING LAYOUT REFER DRAWING NO: PC-21286-1(SHEET 1 OF 4 TO 4 OF 4) AND PC-21287-1.
 4. FOR P&ID REFER DRAWING No: PC-21232-1 R4, PC-21233-0 R3 & PC-21234-2 R3.

Protech Consultants Pvt. Ltd.,
 OFFICE: 173 T.T.K ROAD ALWARPET CHENNAI-600 018

PIPING ISOMETRIC FOR
 CARBON STEEL PIPES