

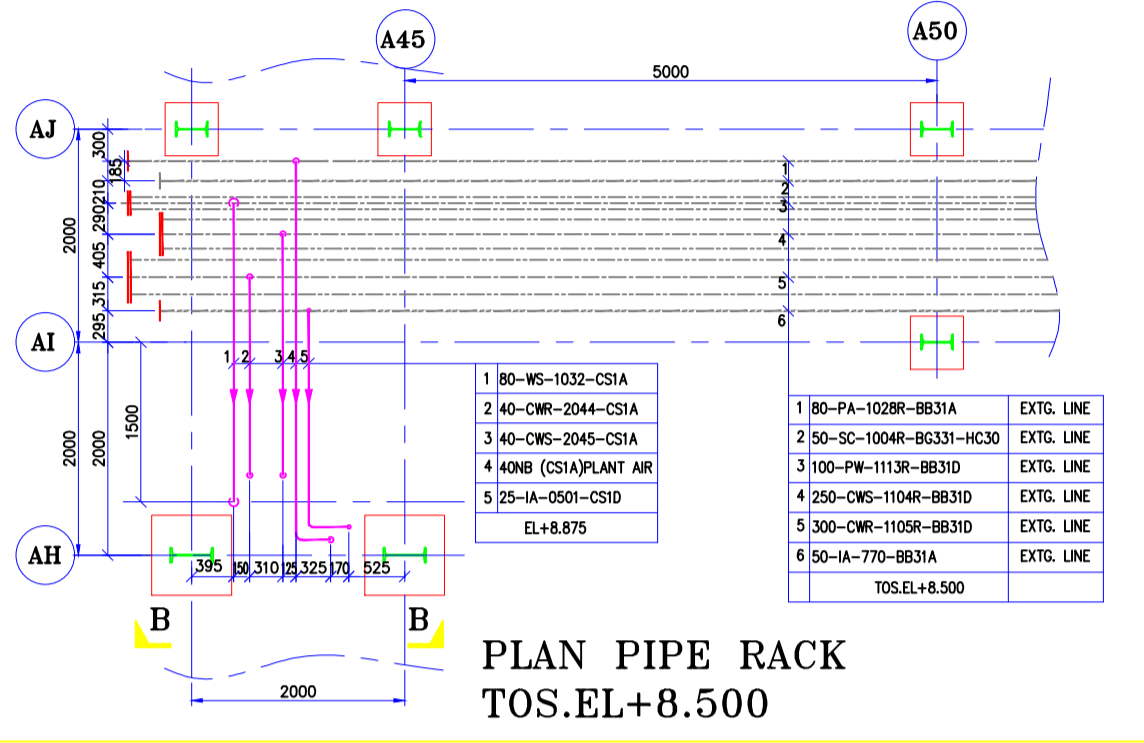



REFER DRAWING No: -  
PC-21286-1 (SHT: 1 OF 4 TO 4 OF 4)  
PIPING LAYOUT

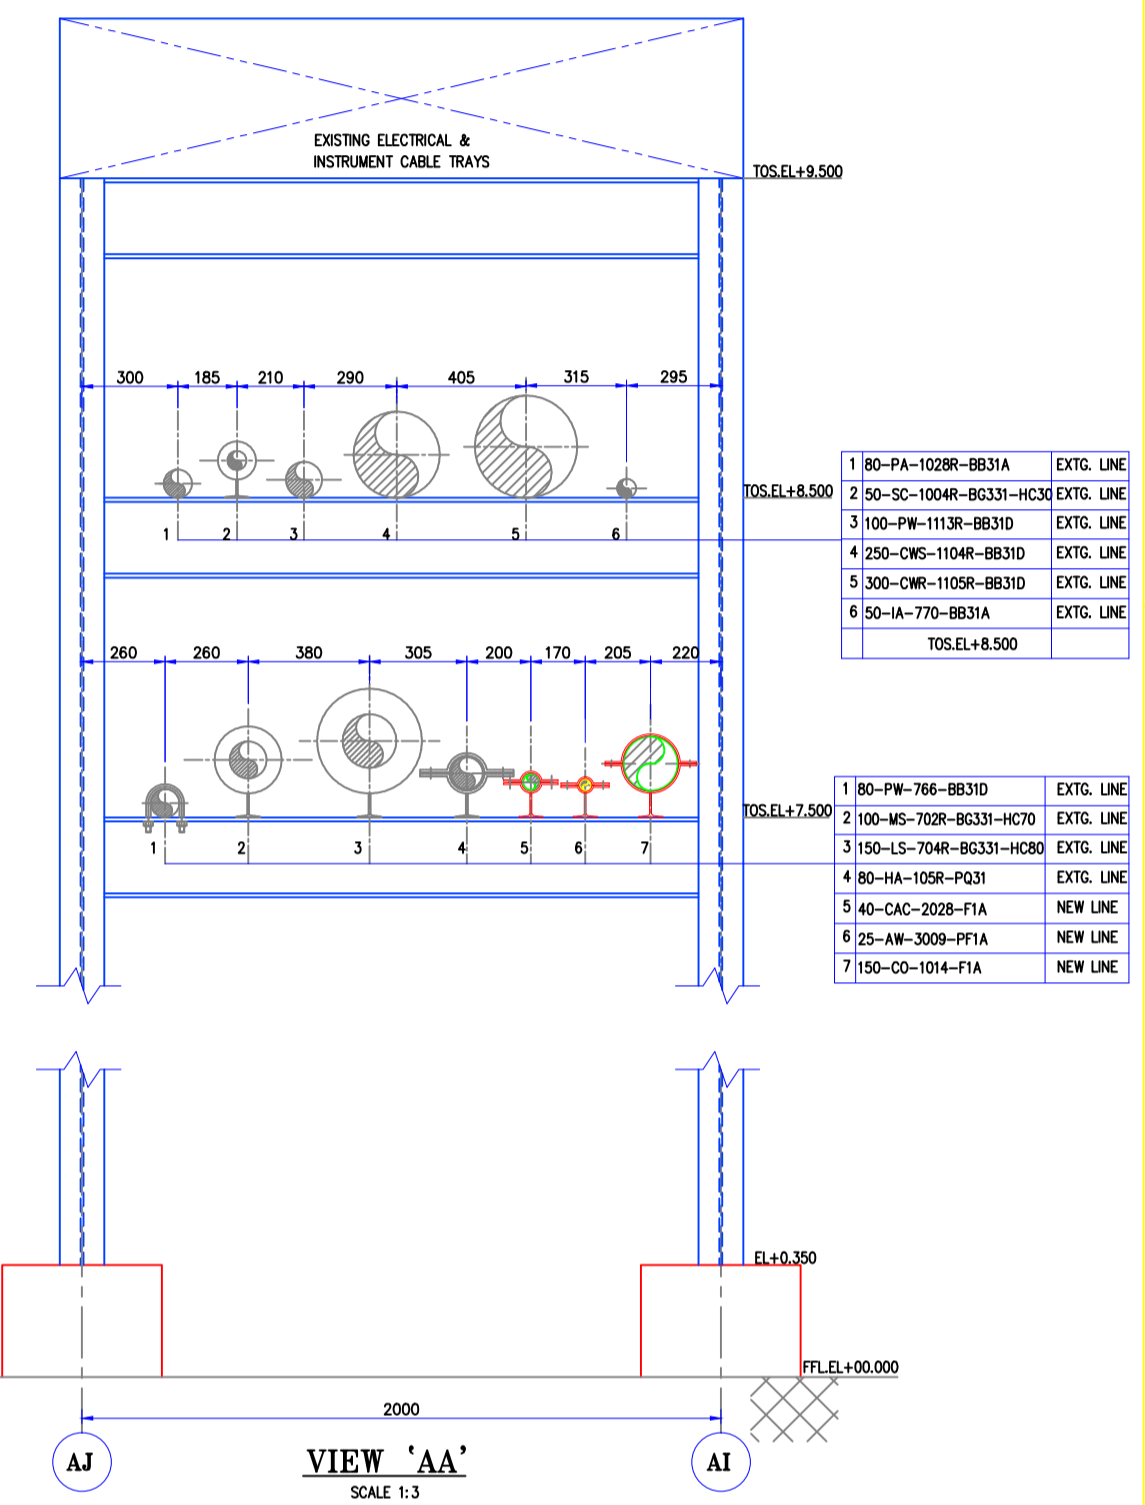


PLAN PIPE RACK  
TOS.EL+8.500

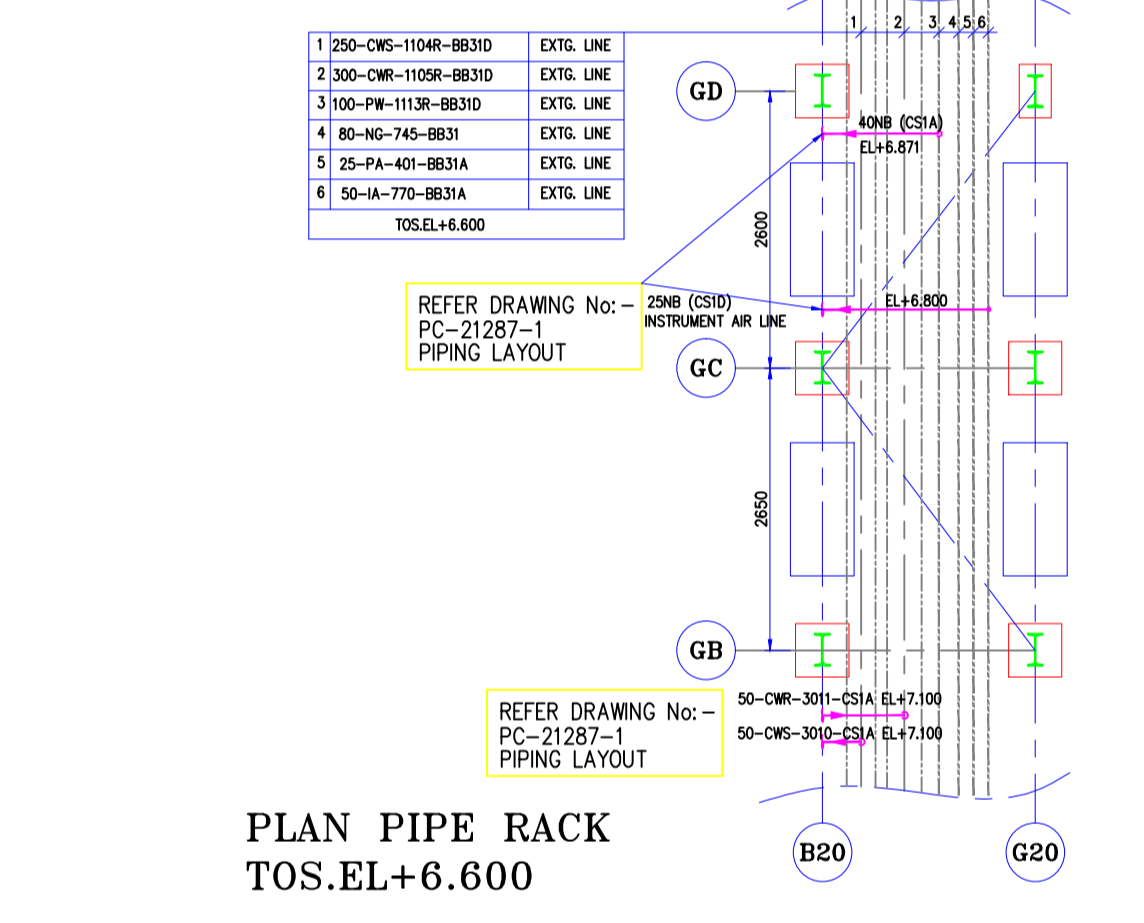

PLAN PIPE RACK  
TOS.EL+6.600

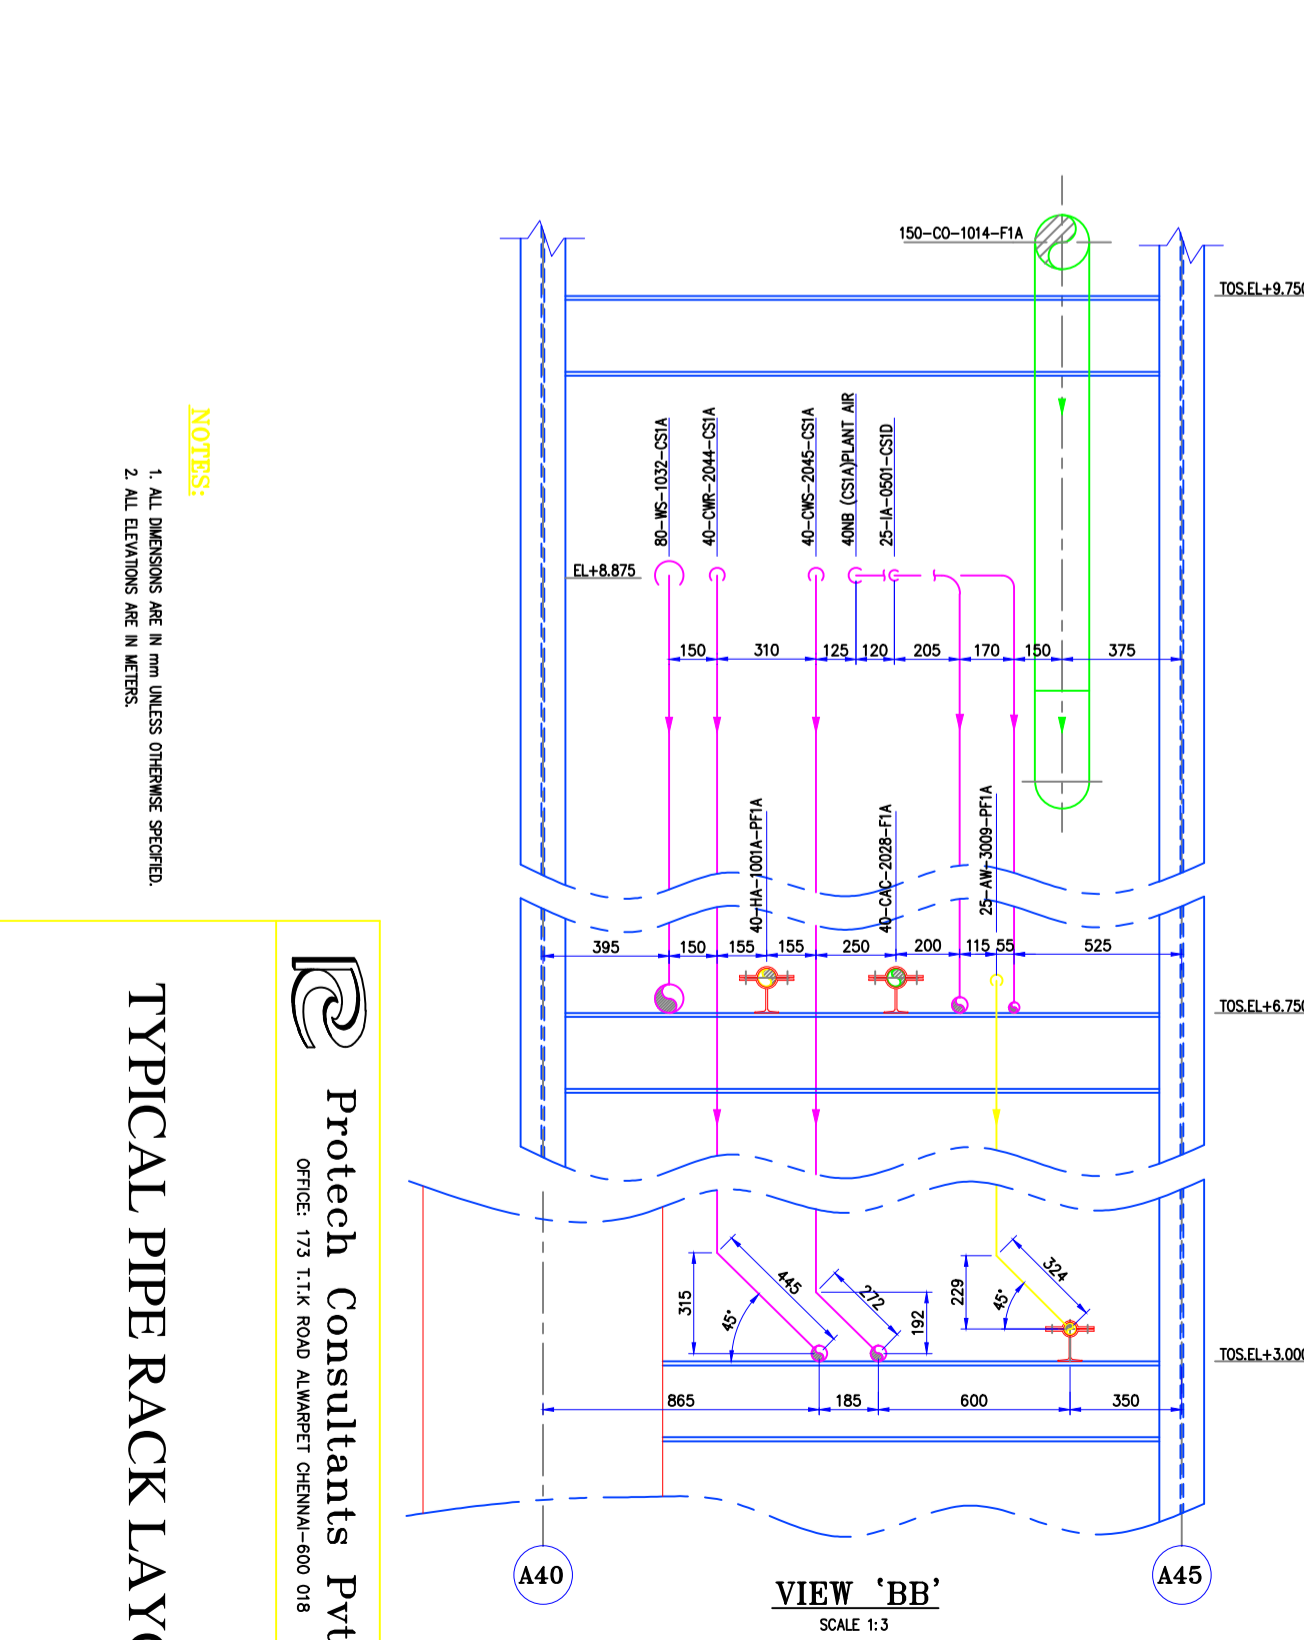

VIEW 'BB'  
SCALE 1:3

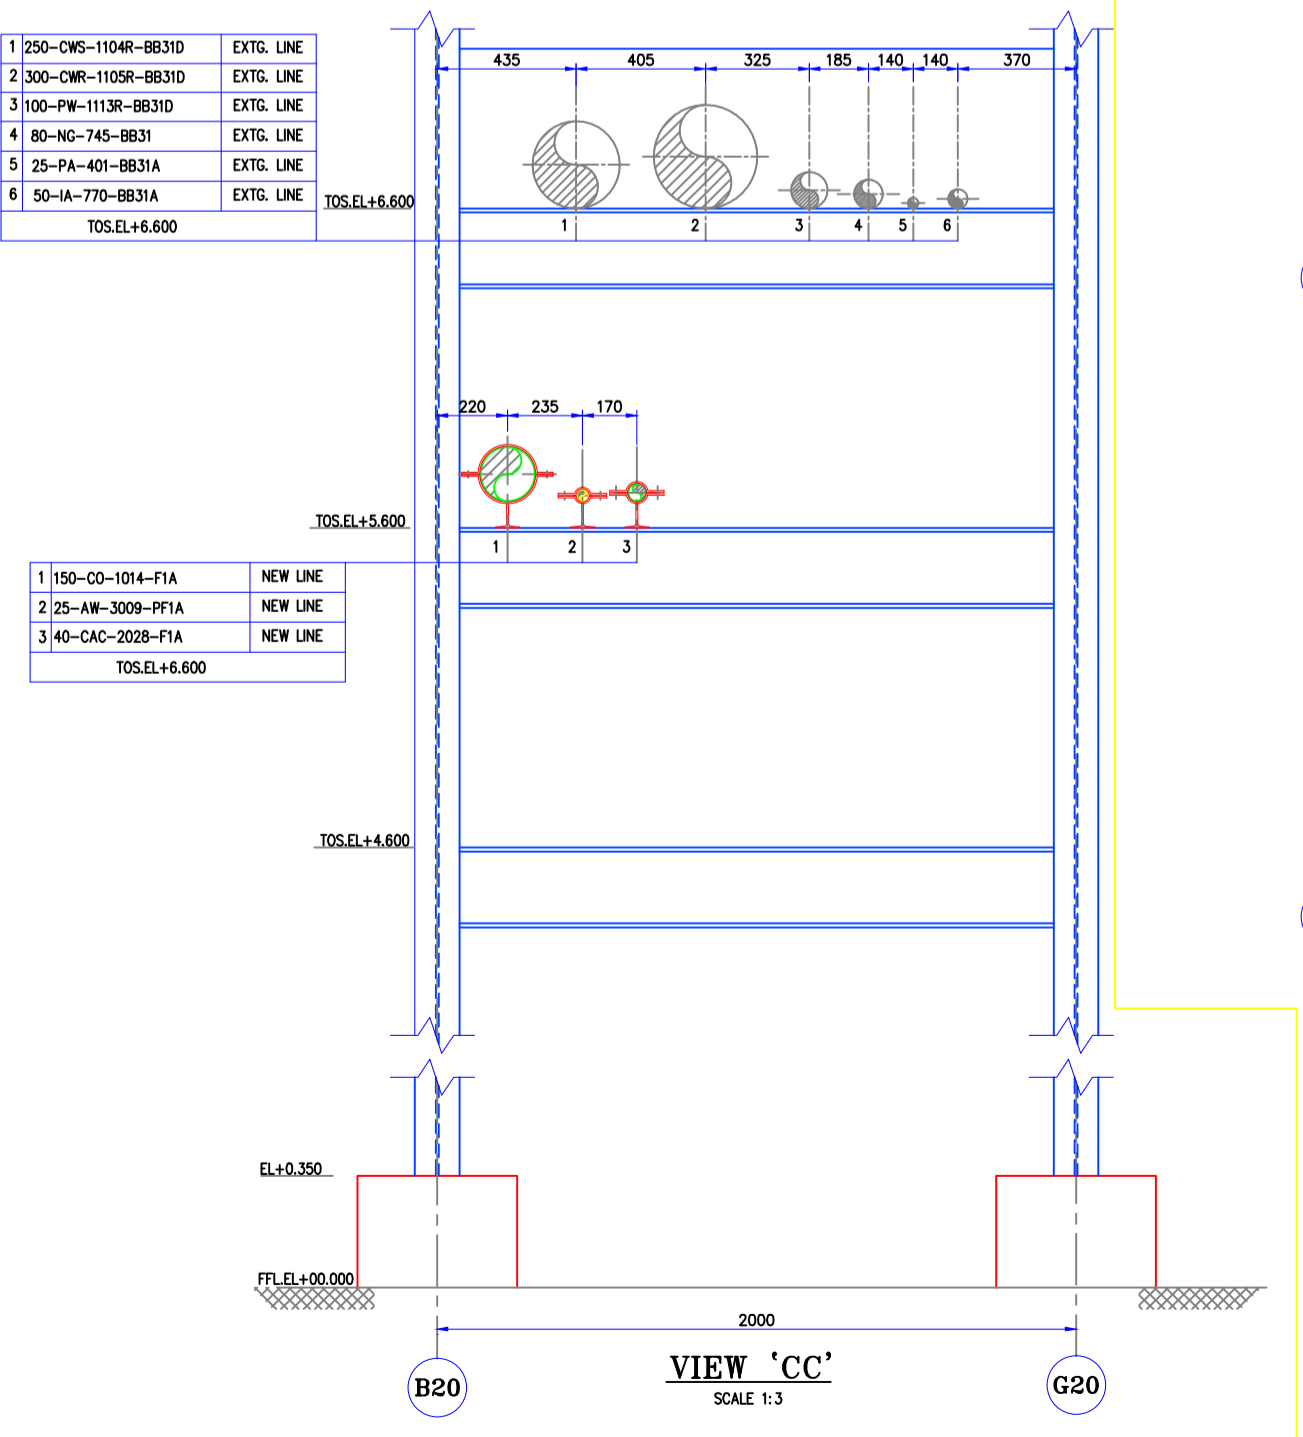

VIEW 'CC'  
SCALE 1:3

REFER DRAWING No: -  
PC-21313-1 (SHT-1 OF 4)  
PIPING LAYOUT FOR  
EVAPORATION UNIT

PLAN PIPE RACK  
TOS.EL+5.600

Protech Consultants Pvt. Ltd.,  
OFFICE: 173 T.I.K. ROAD ALWARPET CHENNAI-600 016

TYPICAL PIPE RACK LAYOUT